








1. General Floor Plan
2. Floor & Loading Specifications Plan
3. Door Dimensions
4. Reflected Ceiling & Lighting Plan

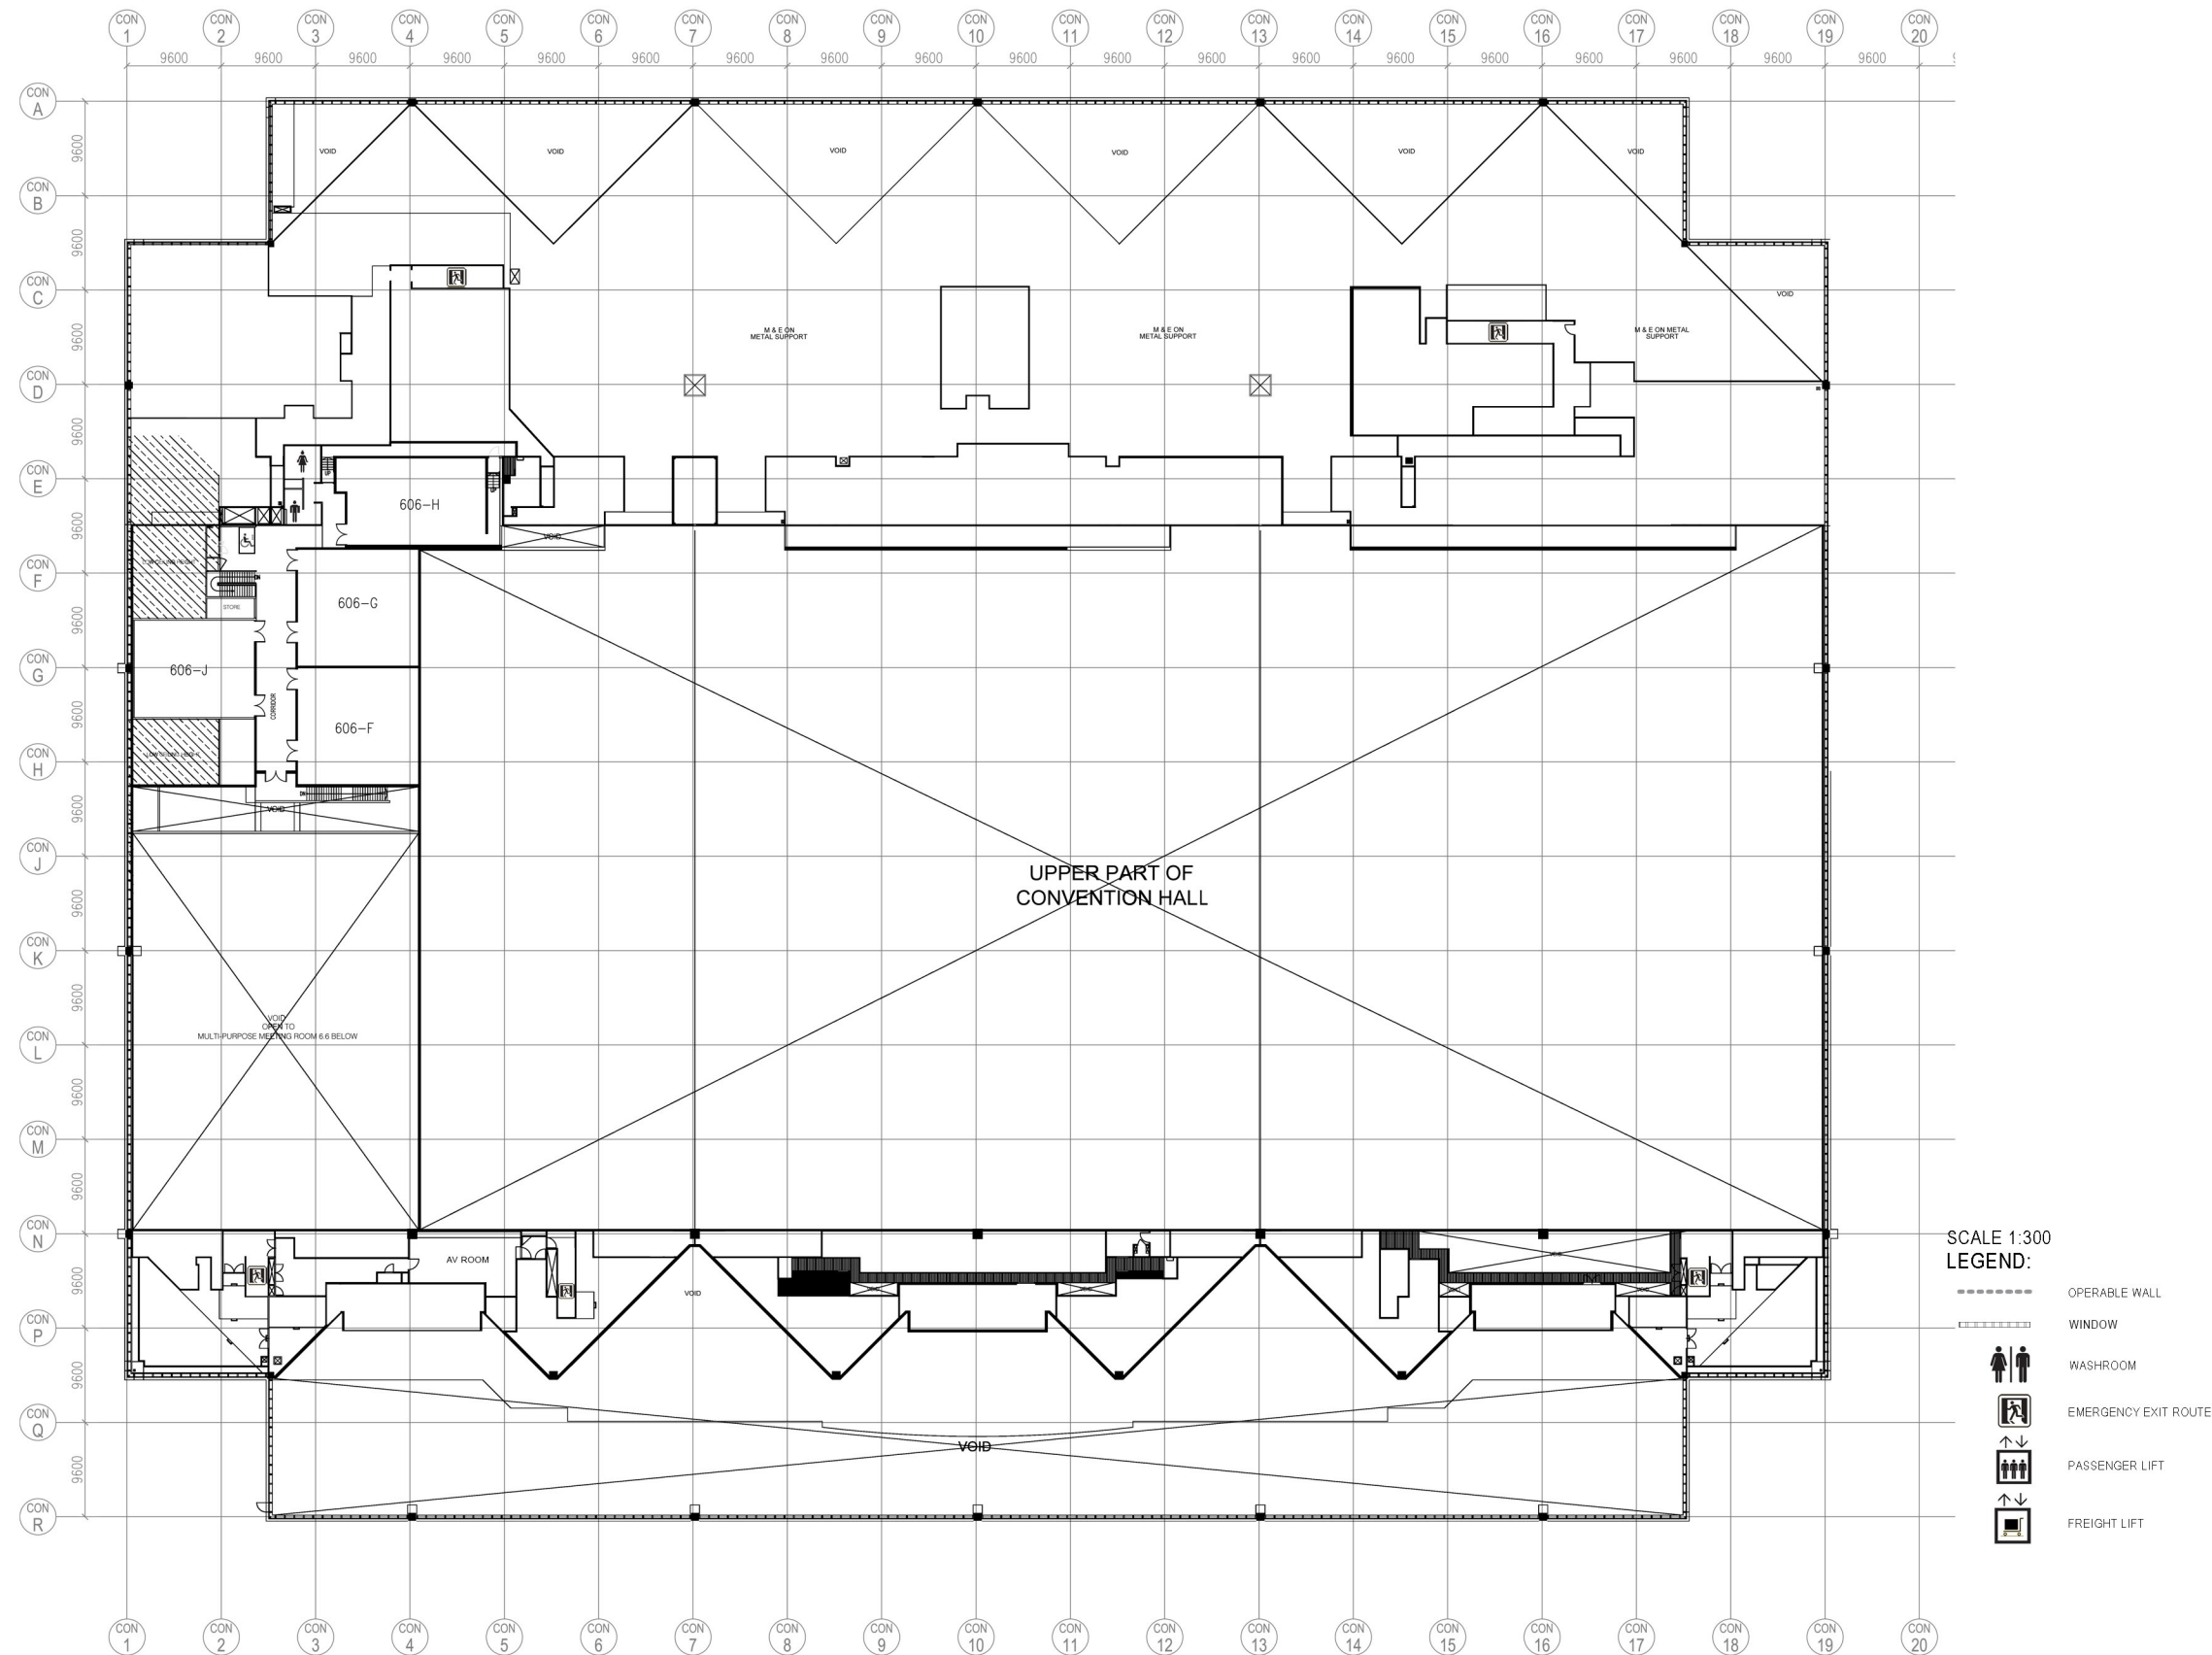




SCALE 1:300
LEGEND:

-  OPERABLE WALL
-  WINDOW
-  WASHROOM
-  EMERGENCY EXIT ROUTE
-  PASSENGER LIFT
-  FREIGHT LIFT

FLOOR SPECIFICATIONS

- All rooms and foyers are carpeted.

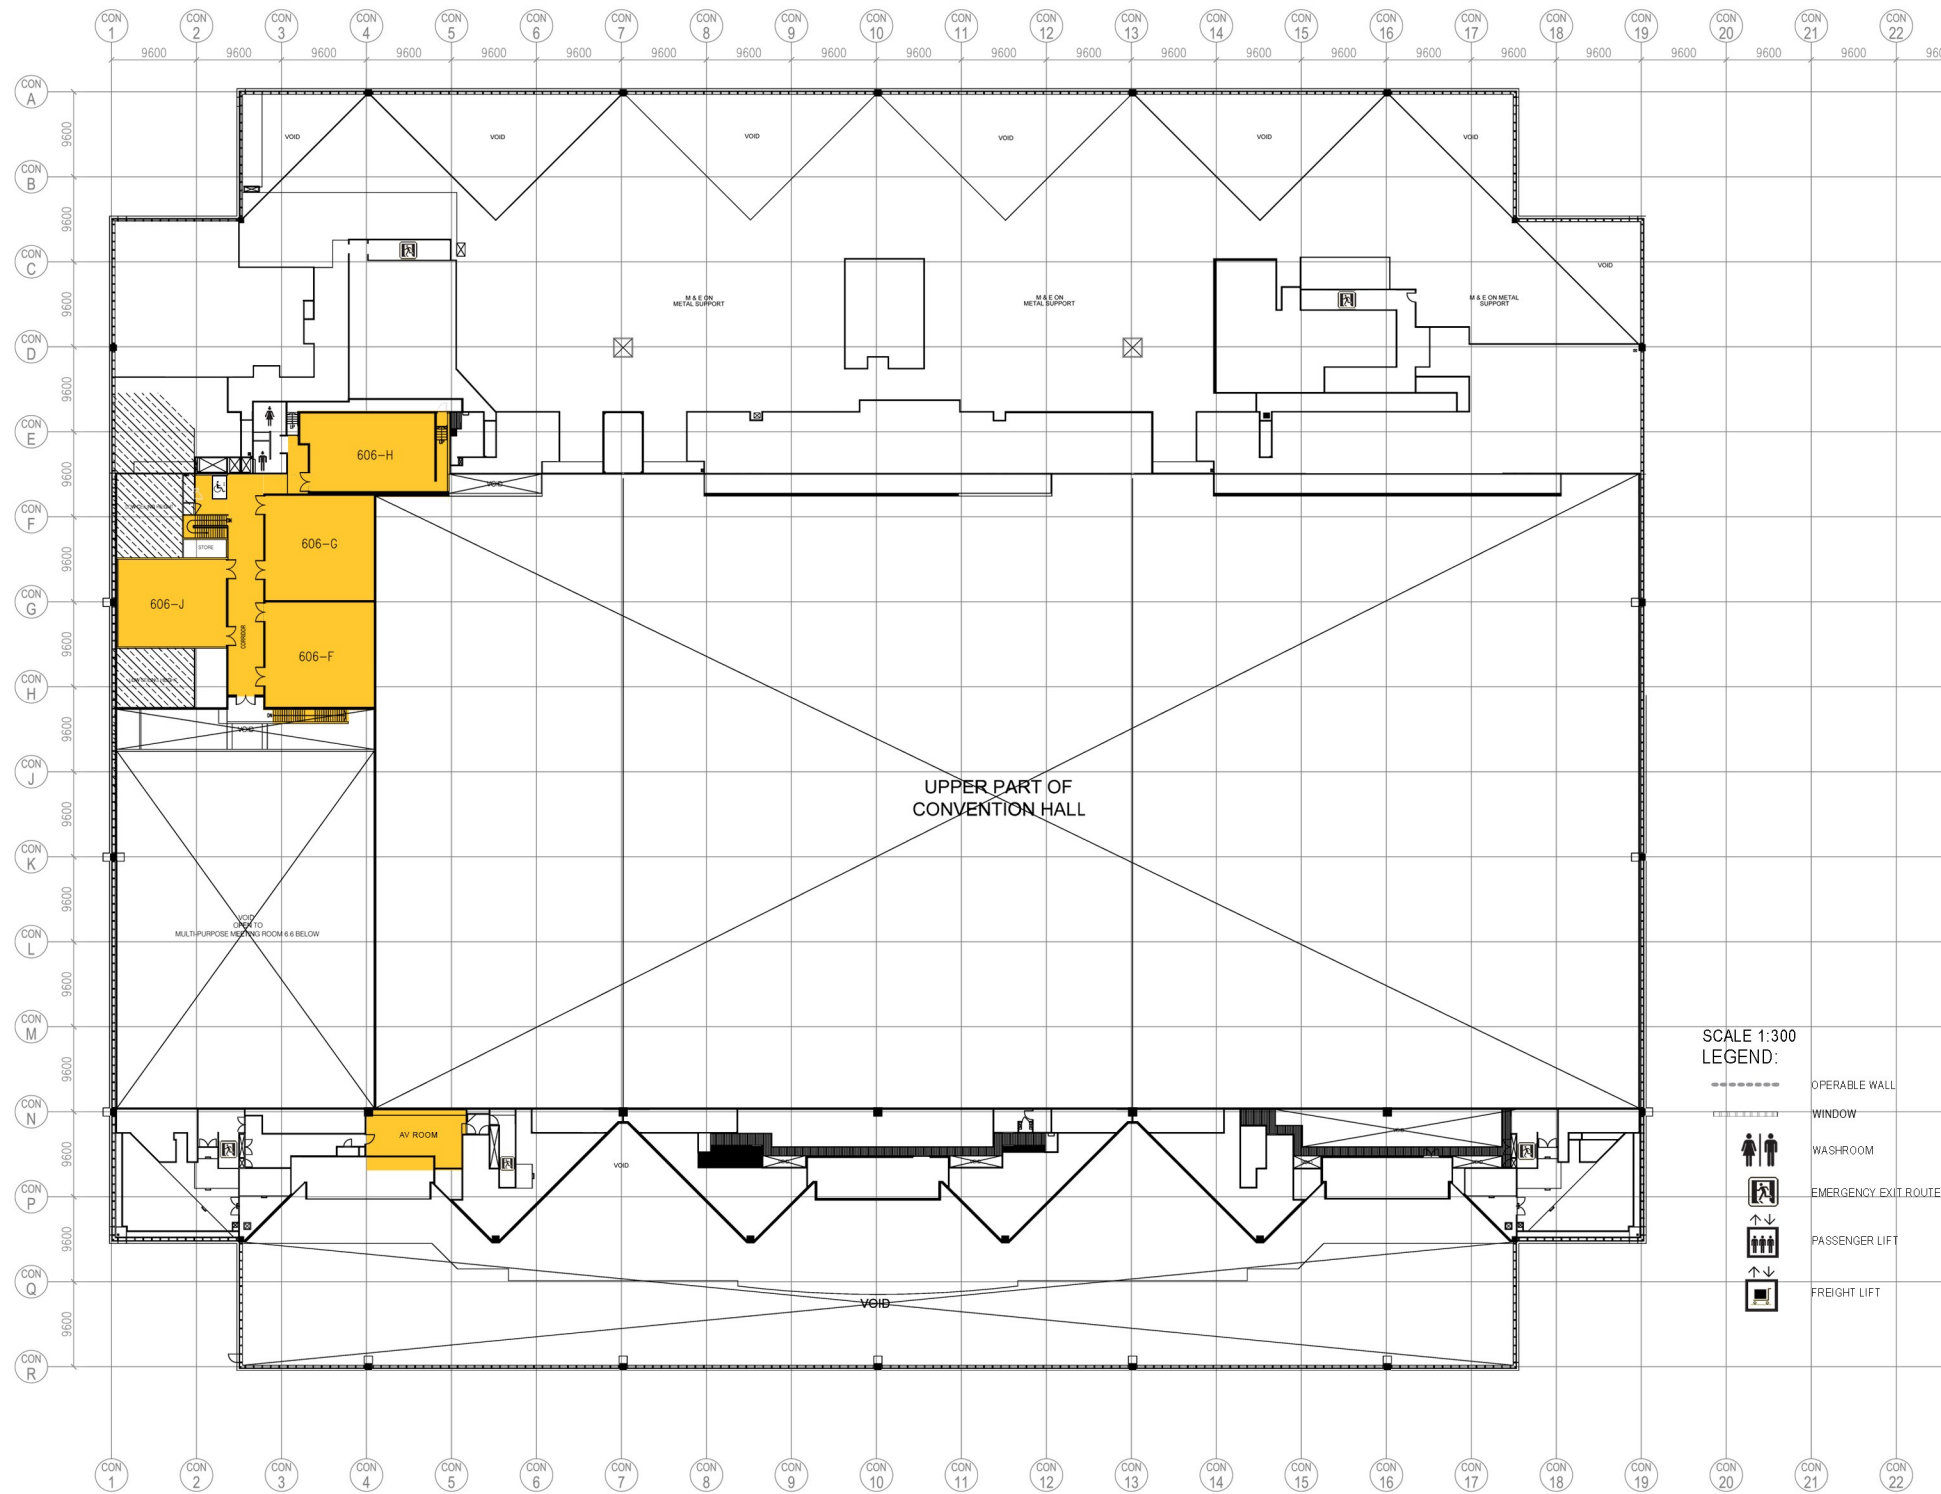


FLOOR LOAD CAPACITY

Floor Load Capacity: 3.0 KN/m² (62 lb/sq ft)

WALL 1
GRIDLINE CON F


GRIDLINE CON j

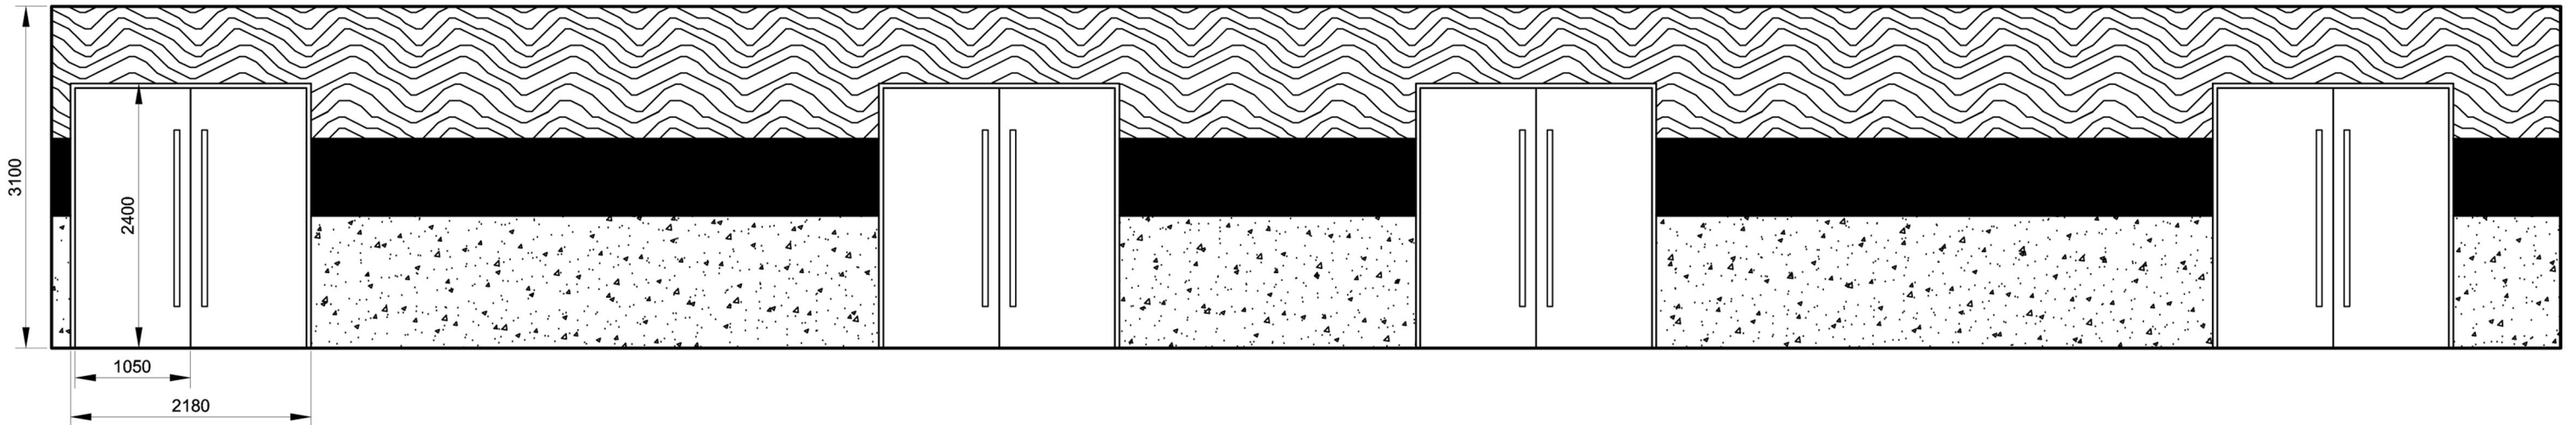


Scale 1:75


WALL 2
GRIDLINE CON F

GRIDLINE CON G

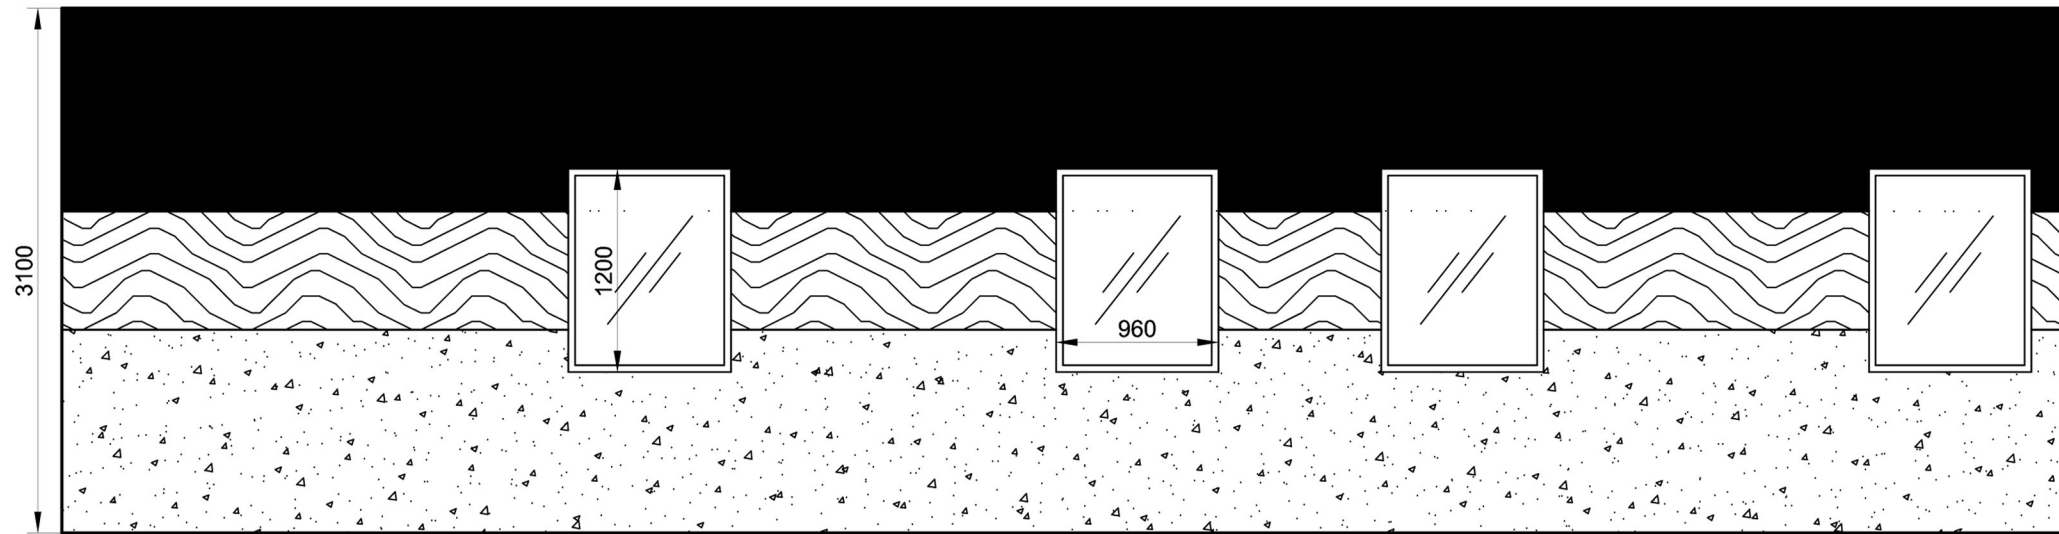

Scale 1:50

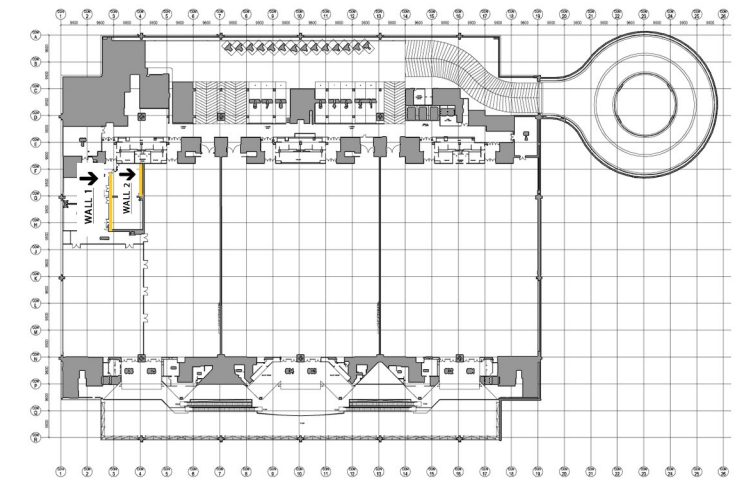

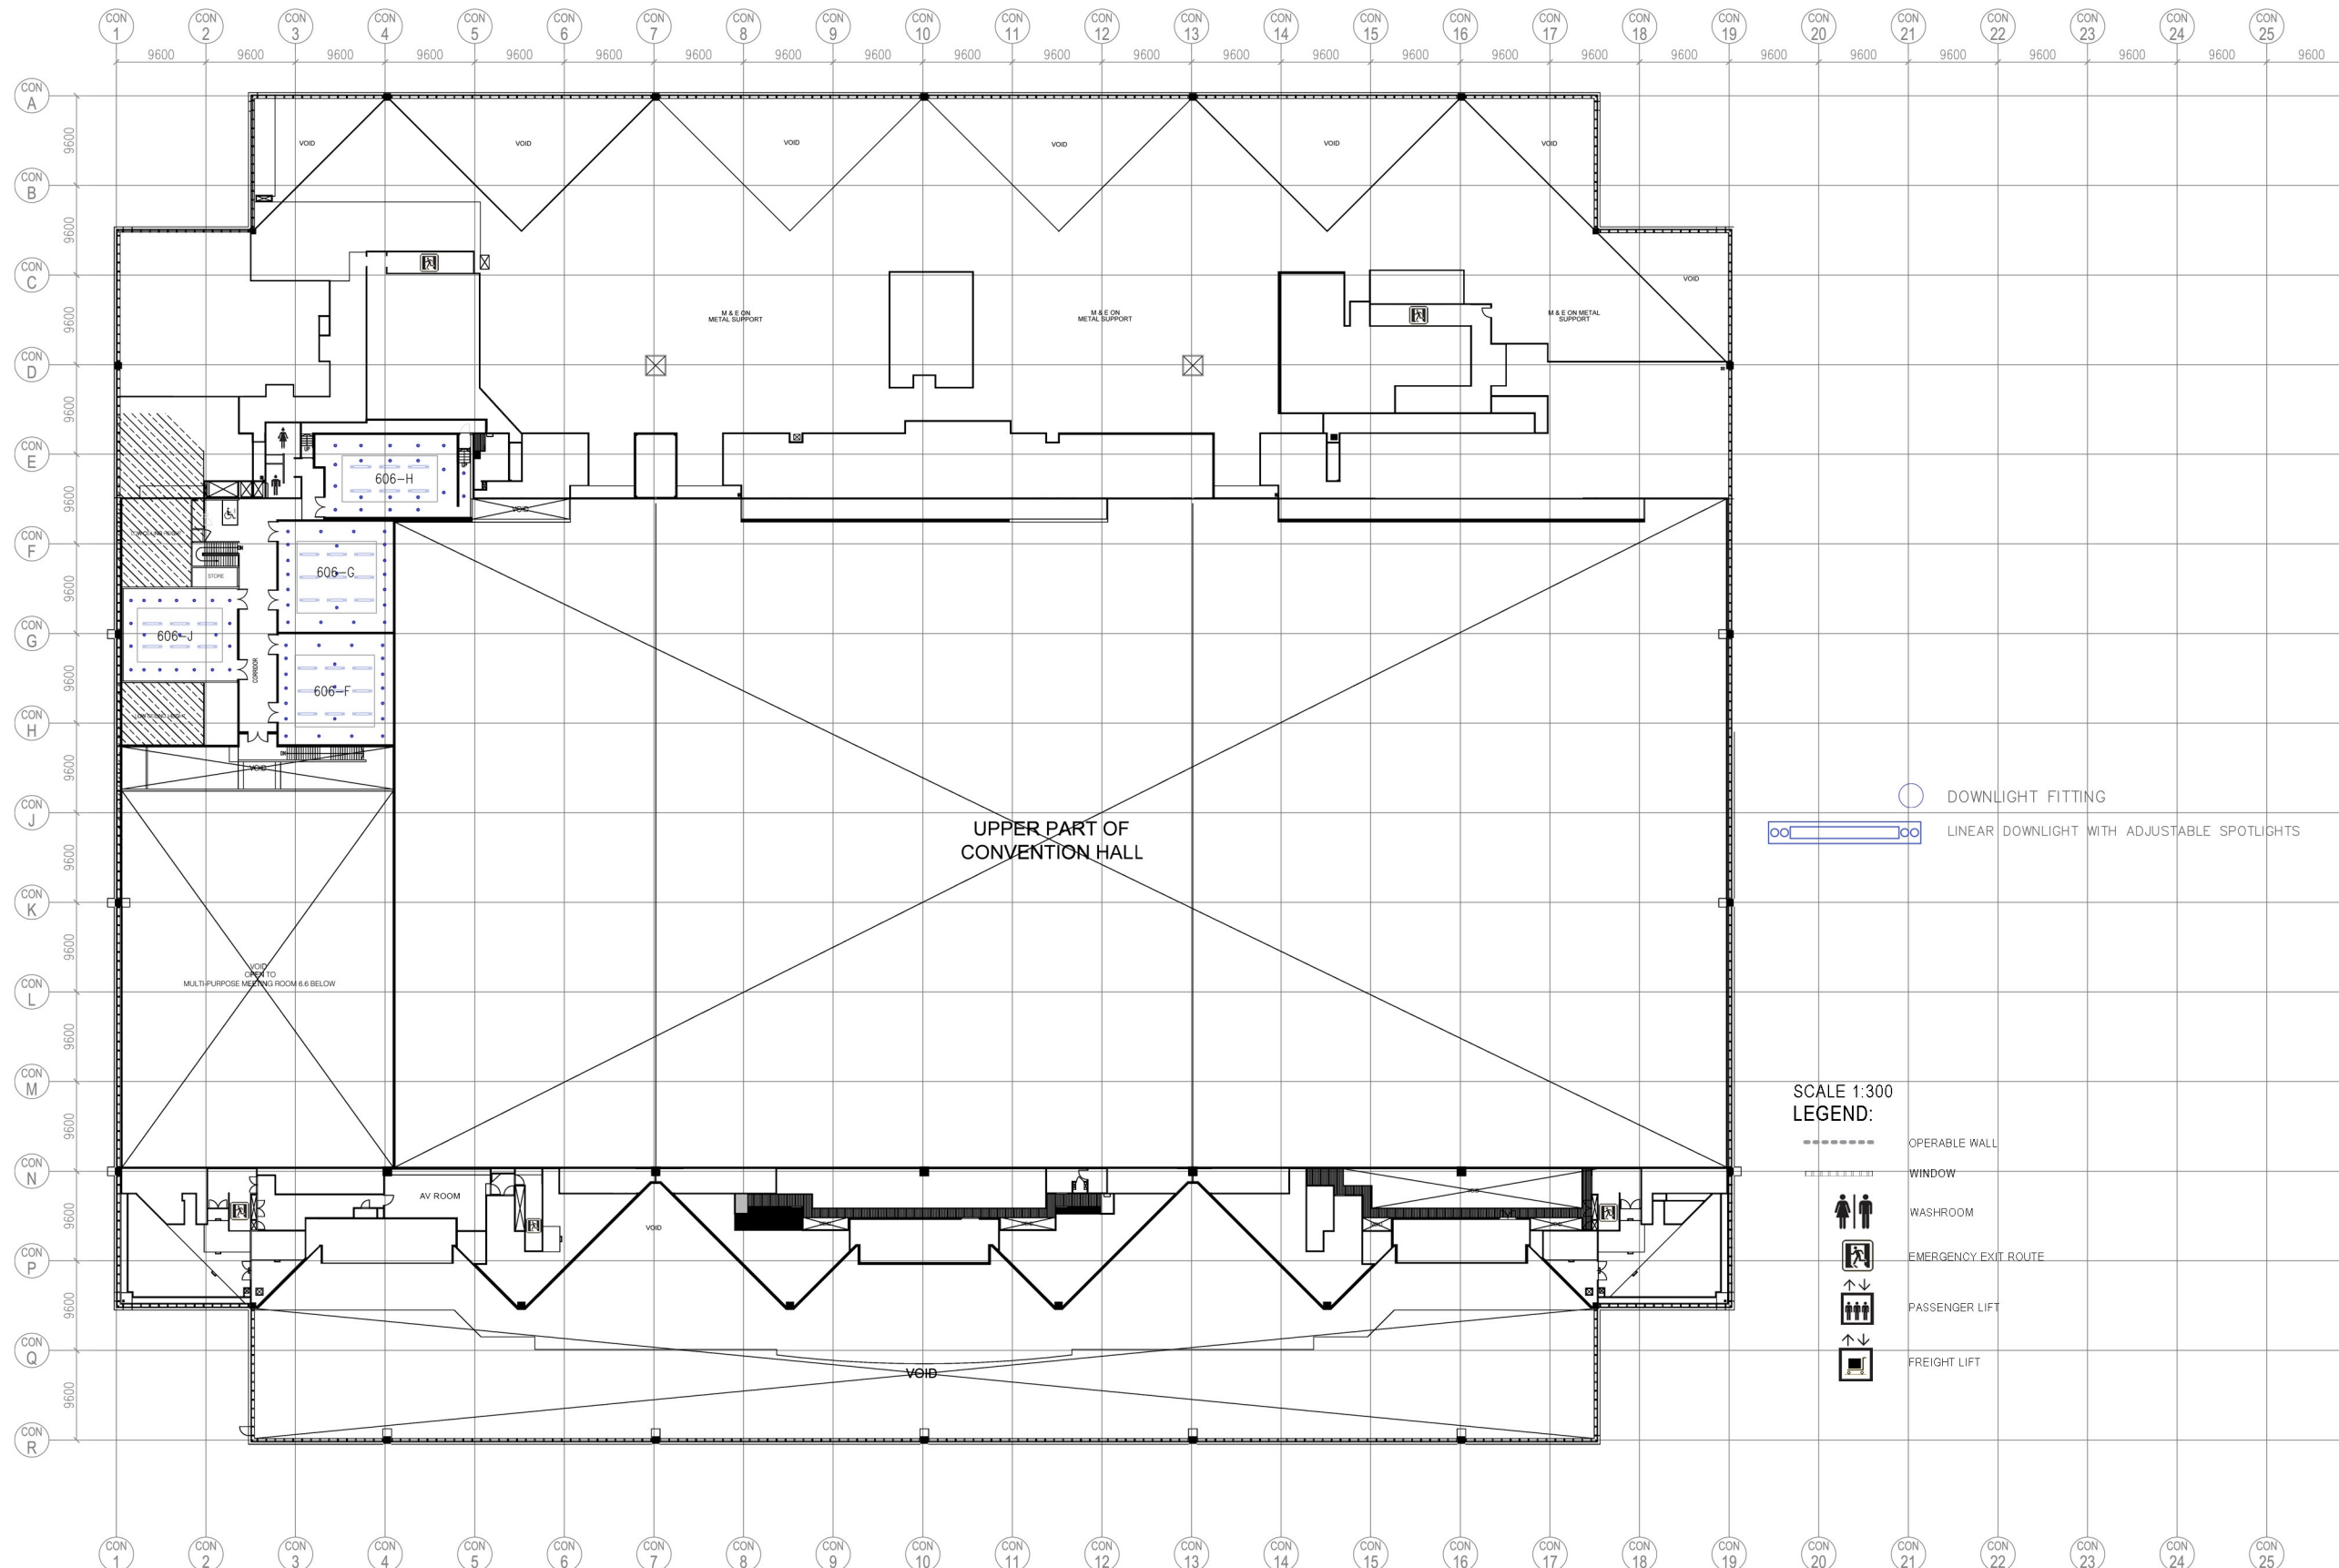

Scale 1:650